

SITE FURNITURE PER THE CITY OF SAN MARCOS APPROVED MATERIALS LIST:

- 1

PICNIC TABLES: BY QCP CORP (951)737-6240, CONTACT: CYNTHIA CHAVEZ. MODEL # QCP-QLBT96PT MODIFIED WITH ANTI-SKATE BOARD INDENTATIONS, COLOR HARVEST, TEXTURE -CRAFTSMAN ETCH, STANDARD SEALER 4200. (QUANTITY: TWO)

A

LC-6
- 2

ADA PICNIC TABLES: BY QCP CORP (951)737-6240, CONTACT: CYNTHIA CHAVEZ. MODEL # QCP-QLBT96PT MODIFIED WITH ANTI-SKATE BOARD INDENTATIONS, COLOR HARVEST, TEXTURE -CRAFTSMAN ETCH, STANDARD SEALER 4200. (QUANTITY: TWO)

C

LC-6
- 3

BENCHES: BY QCP CORP (951)737-6240, CONTACT: CYNTHIA CHAVEZ. MODEL # QCP-Q1FLEX72B, COLOR HARVEST, TEXTURE -CRAFTSMAN ETCH, STANDARD SEALER 4200. (QUANTITY: FOUR)

B

LC-6
- 4

WASTE CONTAINERS: BY QCP CORP (951)737-6240, CONTACT: CYNTHIA CHAVEZ. MODEL # QCP-QRCAL2436WHOV19 MODIFIED WITH 2-INCH HIGH SANDBLASTED AND PAINTED SAN MARCOS LOGO WITH BROWN STEEL HOVER LID-HOV 19, COLOR HARVEST, TEXTURE -CRAFTSMAN ETCH, STANDARD SEALER 4200. (QUANTITY: TWO)

M1

LC-6
- 5

RECUCLD CONTAINERS: BY QCP CORP (951)737-6240, CONTACT: CYNTHIA CHAVEZ. MODEL # QCP-QRCAL2436WHOV19-REC MODIFIED WITH (1) RECYCLE LOGO INSERT AND PAINTED QC STANDARD GREEN WITH GREEN STEEL HOVER LID-HOV 19 WITH VERBIAGE STENCILED WHITE TO READ "BOTTLES AND CANS ONLY" 180 DEGREES APART, COLOR HARVEST, TEXTURE -CRAFTSMAN ETCH, STANDARD SEALER 4200. (QUANTITY: TWO)

M2

LC-6
- 6

CHARCOAL BARBECUE GRILL: LITTLE TIKES COMMERCIAL, PEDESTAL MOUNT, PRODUCT #: LTPQG01N, VANDAL-RESISTANT FIREBOX, COLOR: BLACK, (800) 325-8828, LITTLETIKESCOMMERCIAL.COM. (QUANTITY: ONE)

E

LC-7
- 7

HOT ASH CONTAINER: BY QCP CORP (951)737-6240, CONTACT: CYNTHIA CHAVEZ. MODEL # QCP-QPSHA2842 WHITE LETTERS, RED BACKGROUND, REAR ACCESS DOOR, TEXTURE -CRAFTSMAN ETCH, STANDARD SEALER 4200. (QUANTITY: ONE)

D

LC-6
- 8

PLAYGROUND EQUIPMENT: SHALL BE BY PLAYCRAFT SYSTEMS AND DESIGNED BY PACIFIC PLAY SYSTEMS, INC. OF CARLSBAD, CA. PLAY STRUCTURES # R5H8C60CA, FREPC1920, FREF2EC4A AND FREPC2496SL. CONTACT: ALI BEMANIAN AND MIKE HULSHOF @ PACIFIC PLAY SYSTEMS, INC. (760)599-7355. REFER TO SHEET LC-XX FOR ADDITIONAL INFORMATION.

(SEE SHEET LC-5)
- 9

BIKE RACKS: SHALL BE BY DERO COMMERCIAL BIKE RACKS, ROLLING RACK STYLE, MODEL # RR2H, 3-5 BIKES, 38" LENGTH, (888) 337-6729 OR APPROVED EQUAL. BIKE RACKS SHALL BE GALVANIZED, POWDER COAT AND BLACK COLOR. INSTALL SURFACE MOUNT PER MANUFACTURER'S SPECIFICATIONS AND RECOMMENDATIONS. (QUANTITY: ONE)

H

LC-7
- 10

SHADE STRUCTURES: BY ULTRASHELTER (800)458-5872 MODEL # SQ16S-ML SQUARE 16-FEET SHELTER AND HP1620S-ML HIP RECTANGULAR 16'X20' SHELTER. CONTACT: ALI BEMANIAN AND MIKE HULSHOF @ PACIFIC PLAY SYSTEMS, INC. (760)599-7355.

F,G & J

LC-7
- 11

PEDESTRIAN LIGHT: BY CRI LIGHTING SALES. CATALOG # ARE-EDR-5M-R5-E-UL-BK-700-ML2-40K WITH XA-BRDSPK BIRD SPIKES. INSTALL ON 12-FEET HIGH ROUND STEEL POLE CATALOG # PS5R12CT-BK. (QUANTITY: THREE)

(SEE SITE ELECTRICAL PLANS)
- 12


BASKETBALL POST, BACKBOARD AND GOAL RIM: BY PSS PERFORMANCE SPORTS SYSTEM, GARED HOLDINGS, LLC OF NOBLESVILLE, IN. INSTALL PER MANUFACTURER'S SPECIFICATIONS AND RECOMMENDATIONS.
 - BRACED GOOSENECK POST: MODEL # GN 60R (REAR MOUNT GOAL)
 - PLAYGROUND MARKED STEEL BASKETBALL BACKBOARD: 1260B
 - PLAYGROUND DOUBLE RING BREAKAWAY BASKETBALL RING: MODEL # 5500CONTACT: ALI BEMANIAN AND MIKE HULSHOF @ PACIFIC PLAY SYSTEMS, INC. (760)599-7355. (QUANTITY: ONE EACH)

I

LC-7
- 13

PET STATION: BY DOGIPOT OF ORLANDO, FL (800)364-7681. WWW.DOGIPOY.COM. PET STATION TO INCLUDE:
 - DOGIPOT ALUMINUM JUNIOR BAG DISPENSER, MODEL 1002-2
 - 10-GALLON STEEL DOGIPOT TRASH RECEPTACLE WITH LID, MODEL 1206-L
 - GALVANIZED STEEL SQUARE TELESCOPIC DOGIPOT POST, MODEL 1301-P, 4' TO 8'
 - ALUMINUM DOGIPOT REFLECTIVE "ON LEASH" PET SIGN, MODEL 1203, 11.5" X 18".(QUANTITY: ONE)

(NOT INCLUDED)

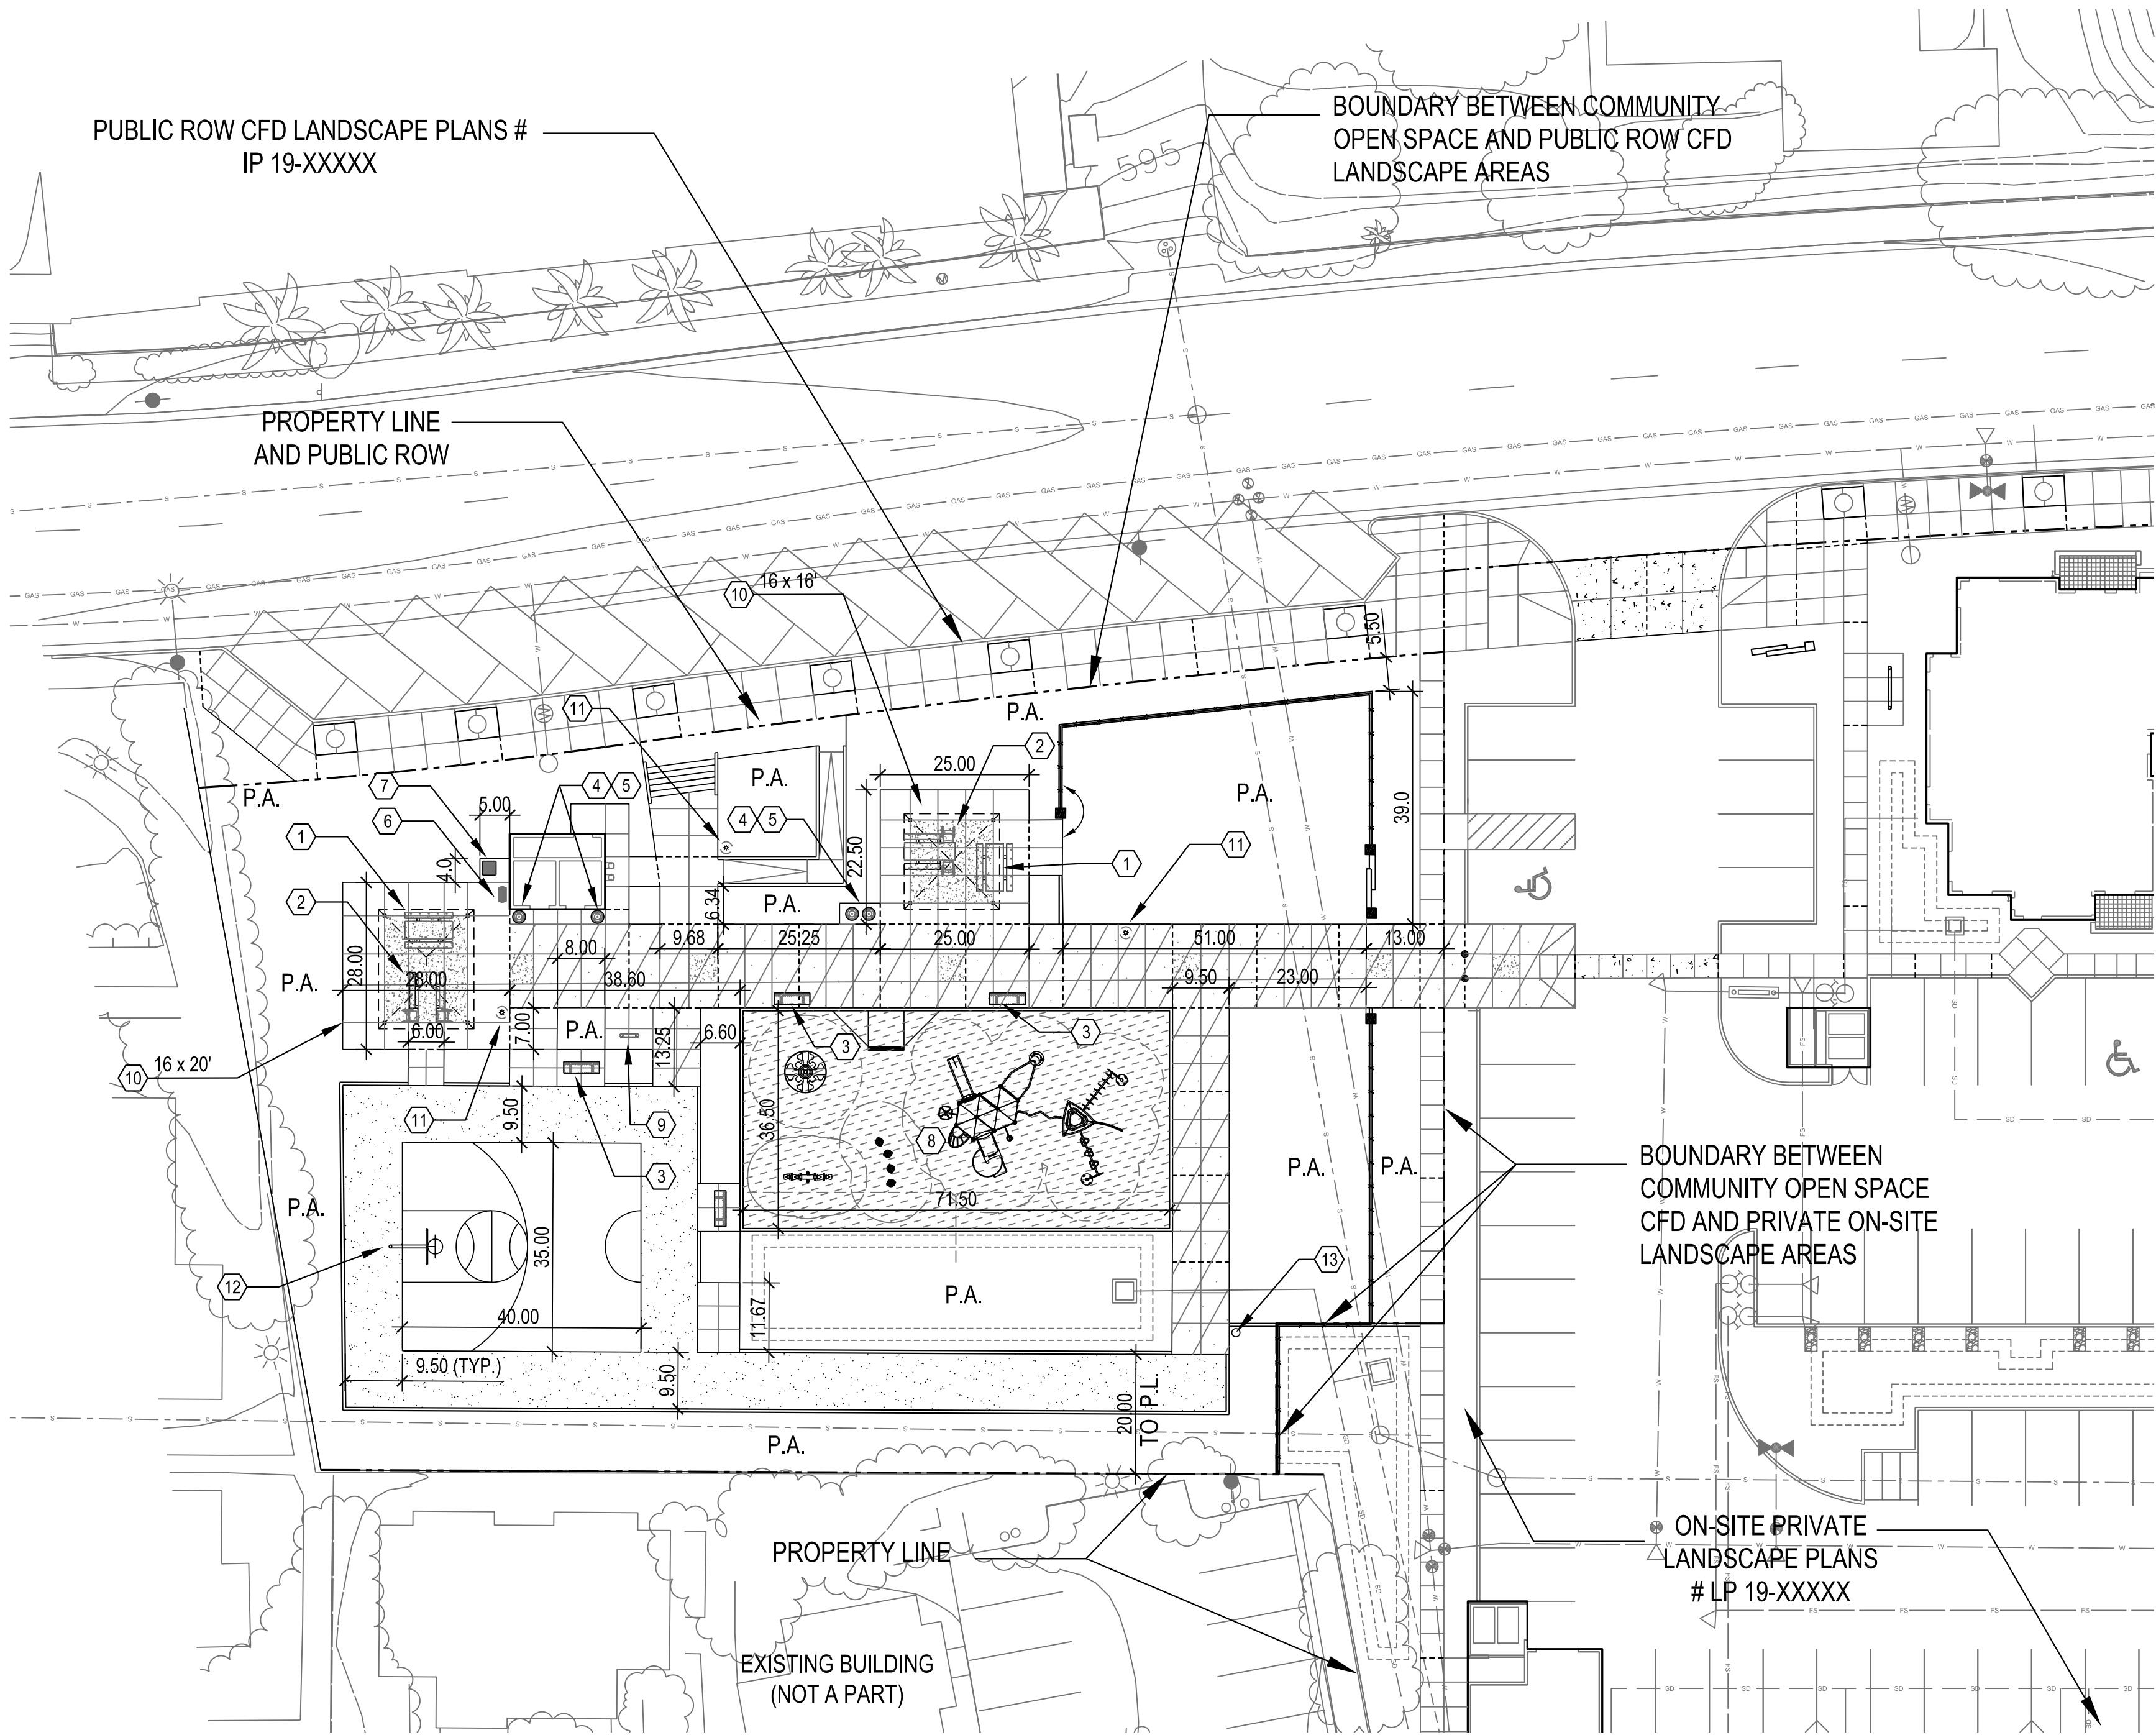

LANDSCAPE CONSTRUCTION STAKING PLAN

PLAN LEGEND

- 10.0'

CL

EQ

P.A.
- ALIGN

CENTERLINE

EQUAL DISTANCE

PLANTING AREA

PLAN REFERENCE NOTES:

- REFER TO CIVIL DRAWINGS FOR ALL GRADING, UTILITIES AND STORM DRAINAGE.
- REFER TO CIVIL DRAWINGS FOR NEW CURB, ASPHALT PAVEMENT, SIDEWALK WITHIN RIGHT-OF-WAY, DRIVEWAY ENTRANCES, BUILDING LOCATIONS AND STAKING.
- REFER TO ARCHITECTURAL DRAWINGS FOR RESTROOM BUILDING.
- REFER TO SITE ELECTRICAL DRAWINGS FOR SITE LIGHTING, IRRIGATION ELECTRICAL POWER CONNECTION AND P AND ELECTRICAL METER SPECIFICATIONS AND LOCATIONS.

SAN MARCOS FIRE DEPARTMENT	VALLECITOS WATER DISTRICT	LANDSCAPE ARCHITECT OF WORK	CITY APPROVED CHANGES	RECOMMENDED FOR APPROVAL	APPROVED FOR CONSTRUCTION	BENCH MARK	CITY OF SAN MARCOS ENGINEERING DIVISION	City Drawing No.
By: _____ Date: _____ JASON NAILON, FIRE MARSHAL APPROVED FIRE HYDRANT FLOW _____	By: _____ Date: _____ JAMES H. GUMPEL P.E. DISTRICT ENGINEER R.L.C. NO. C60160 EXP. 6/30/2020	By: _____ Date: _____ Name: MOHAMED ZAKI R.L.A.: 4430 exp.: 09-30-2020	No. Description App'd By Date	By: _____ Stephanie Kellar, Principal City Engineer R.C.E.: 71461 exp.: 12/31/2020 Date: _____	By: _____ Matt Little, Director of Public Works R.C.E.: 60569 exp.: 12/31/2020 Date: _____	Description: _____ Location: _____ Record From: RECORD OF SURVEY 13928 Elev.: _____ Datum: NGVD88	LANDSCAPE STAKING PLAN FOR: EL DORADO APARTMENTS (COMMUNITY OPEN SPACE CFD LANDSCAPE PLANS) PLANNING PROJECT NO. SDP 13-003 GPA 13-004 TFM 13-003 SP 13-002	IP 19-XXXXX Sheet XX of XX